


描	校
---	---

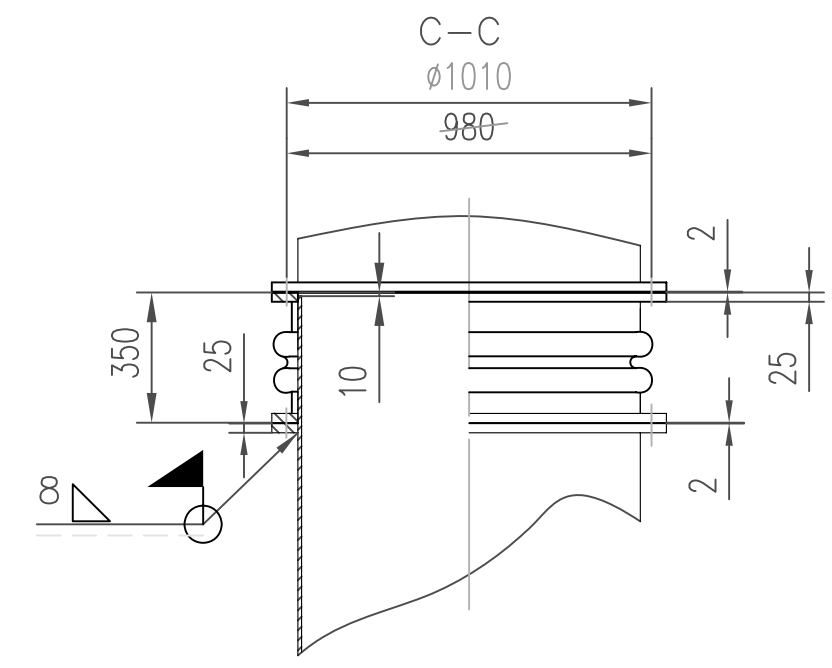

- 1 序号7与序号6现场焊接, 序号7可根据现场实际尺寸切割, 焊接形式见C—C视图。
- 2 现场安装时, 根据现场实际情况可以在适当位置加装吊耳, 吊耳由用户自备。

11	DZMS0015.05.030	STRAIGHT PIPE 管	1	WELDMENT 焊接件	263	263	
10		BOLT M16X90 螺栓M16X90	40	8.8 CLASS	0.16	6.4	
9	DZMS0015.05.01	CUSHION 垫	1	400HEAT RESISTANT RUBBER SLAB	1	1	
8	DZMS0015.05.020	PULVERIZED COAL CONVEYING PIPE 输粉管	1	WELDMENT 焊接件	359	359	
7	DZMS0015.05.010	ELBOW 弯管	1	WELDMENT 焊接件	248	248	
6	DZMS0007.06.01	FLANGE 法兰	2	Q235A	41	82	
5		EXPANSION JOINT 膨胀节	1	BOUGHT-IN 外购件	110	110	
4		CUSHION Ø1060XØ920X2 垫Ø1060XØ920X2	3	400HEAT RESISTANT RUBBER SLAB	0.5	1.5	
3		WASHER 16 垫圈16	136	65Mn	0.008	1.088	
2		NUT M16 螺母M16	136	8 CLASS	0.029	3.944	
1		BOLT M16X80 螺栓M16X80	96	8.8 CLASS	0.15	14.4	
序号	代 号	名 称	数 量	材 料	单件重量 (kg)	总计重量 (kg)	备 注
							类别
REV.	DATE	DESIGNED BY	CHECKED BY	REVIEWED BY	APPROVED BY	DESCRIPTION	
OWNER	VIETNAM ELECTRICITY THERMAL POWER PROJECT MANAGEMENT BOARD 3						
CONSULTANT	POWER ENGINEERING CONSULTING JOINT STOCK COMPANY 2						
CONTRACTOR	DONGFANG ELECTRIC CORPORATION LIMITED						
SUBCONTRACTOR	NORTHERN HEAVY INDUSTRIES GROUP CO.LTD						
DEC REF. No.	DUYEN HAI 1/NHI/MGS4766/DZMS0021.01.11						
MANU REF. No.	MGS4766/DZMS0021.01.11						
PROJECT :	DUYEN HAI 1 THERMAL POWER PLANT PROJECT				CONTRACT NO. : DH1-30032010		
PULVERIZED COAL CONVEYING PIPELINE II							
TITLE 1 : 输粉管道 II							
DESIGNED BY :	张 旭 军	CHECKED BY :	刘 南	SCALE : 1:20			
REVIEWED BY :	张 氏				DATE : 2011.11.11		
APPROVED BY :	张 氏				SUBMITTED FOR: FOR INFORMATION		
STATUS: DETAILED DESIGN		DRAWING NO. : DZMS0015.09.00					REV. 00